


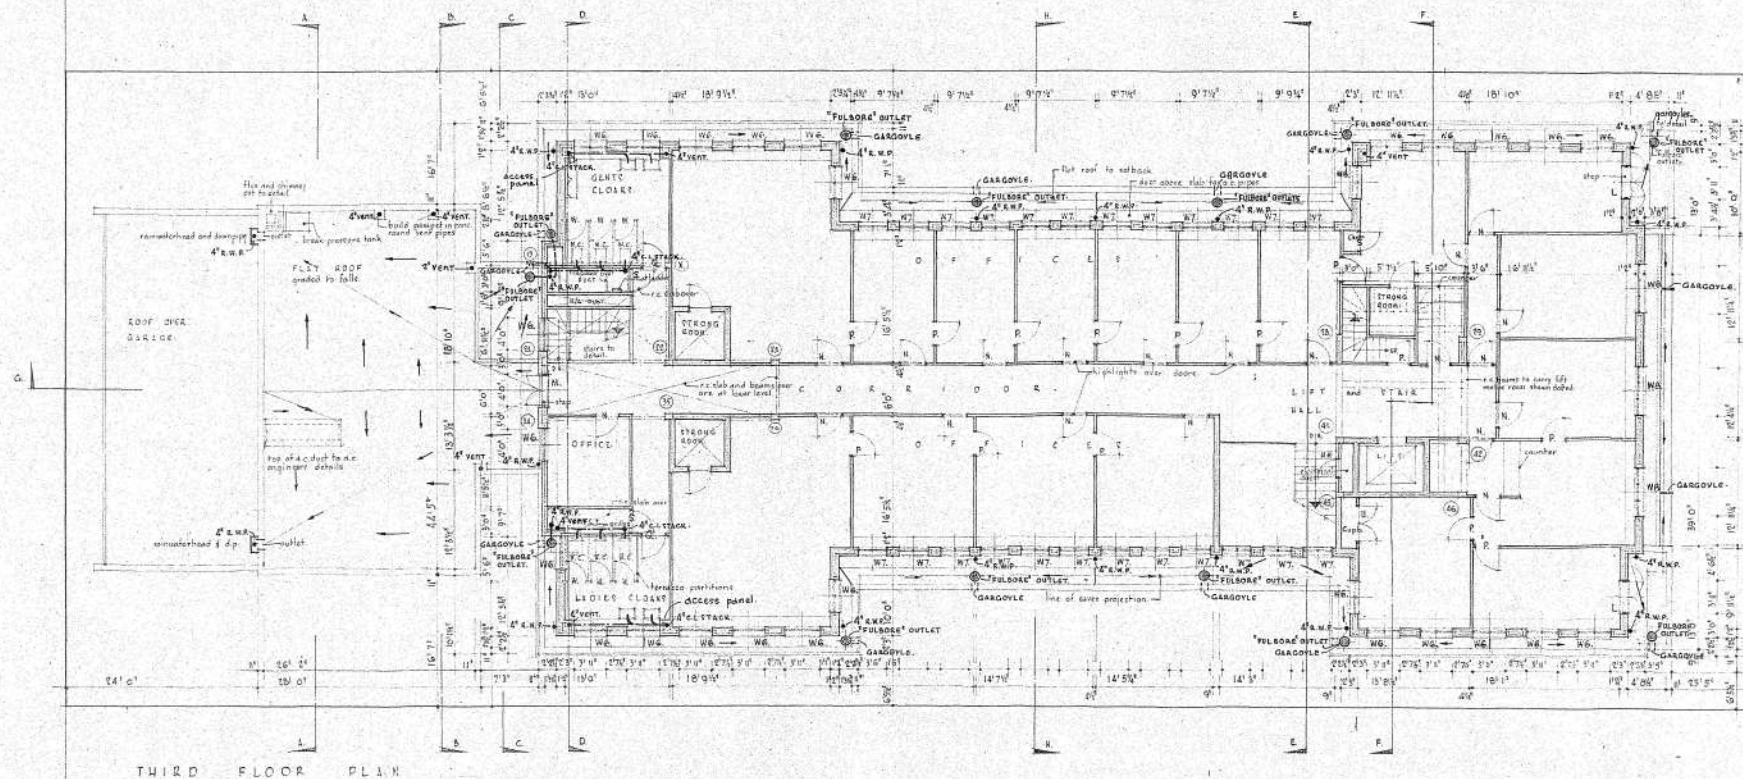

THIRD FLOOR PLAN

For and on behalf of
THE NATAL YACHTING EXTRACT CO., LTD.
G. R. Lamb
AGENTS AND MANAGERS & SECRETARY


SEWERAGE

ERICK, BARTHOLOMEW and POOL,
ARCHITECTS - FURBANK
SCALE 8'0" to 1" FEBR. 1956
DRAWING NO. 1957/47/F16

1/8" SCALE WORKING
DRAWING

NEW OFFICE BLOCK IN LOOP STREET PIETERMARITZBURG FOR THE NATAL TANNING EXTRACT CO, LTD.

CITY ENGINEER'S OFFICE
RECEIVED
17 JUN 1958
PLAN No. 235/58

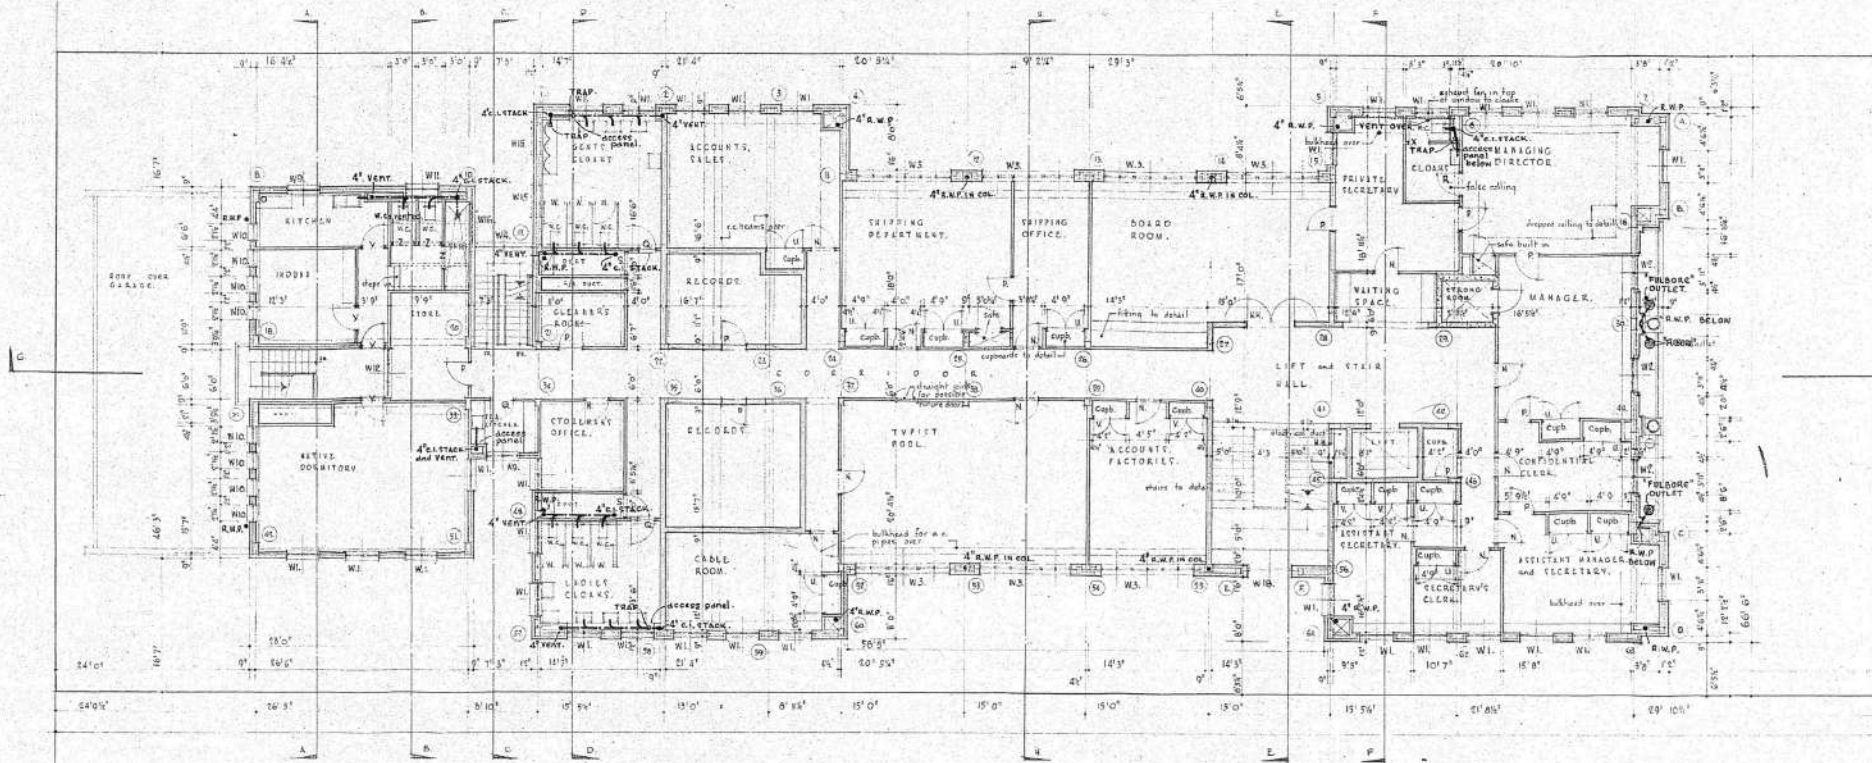

FIRST FLOOR PLAN.


1/8" SCALE WORKING
DRAWING

NEW OFFICE BLOCK IN LOOP STREET, PIETERMARITZBURG FOR THE NATAL TANNING EXTRACT CO, LTD.

For and on behalf of
THE NATAL TANNING EXTRACT CO, LTD.
John Burt
ASSISTANT MANAGER & SECRETARY

SEWERAGE.
CHICK, BARTHOLOMEW and POOLE
ARCHITECTS. 91 BROAD
SCALE 8 1/2" to 1" YEAR 1956
DRAWING NO. 1957/45/P14

CITY ENGINEERS OFFICE
RECEIVED
17 JUN 1958
PLAN NO 235/61

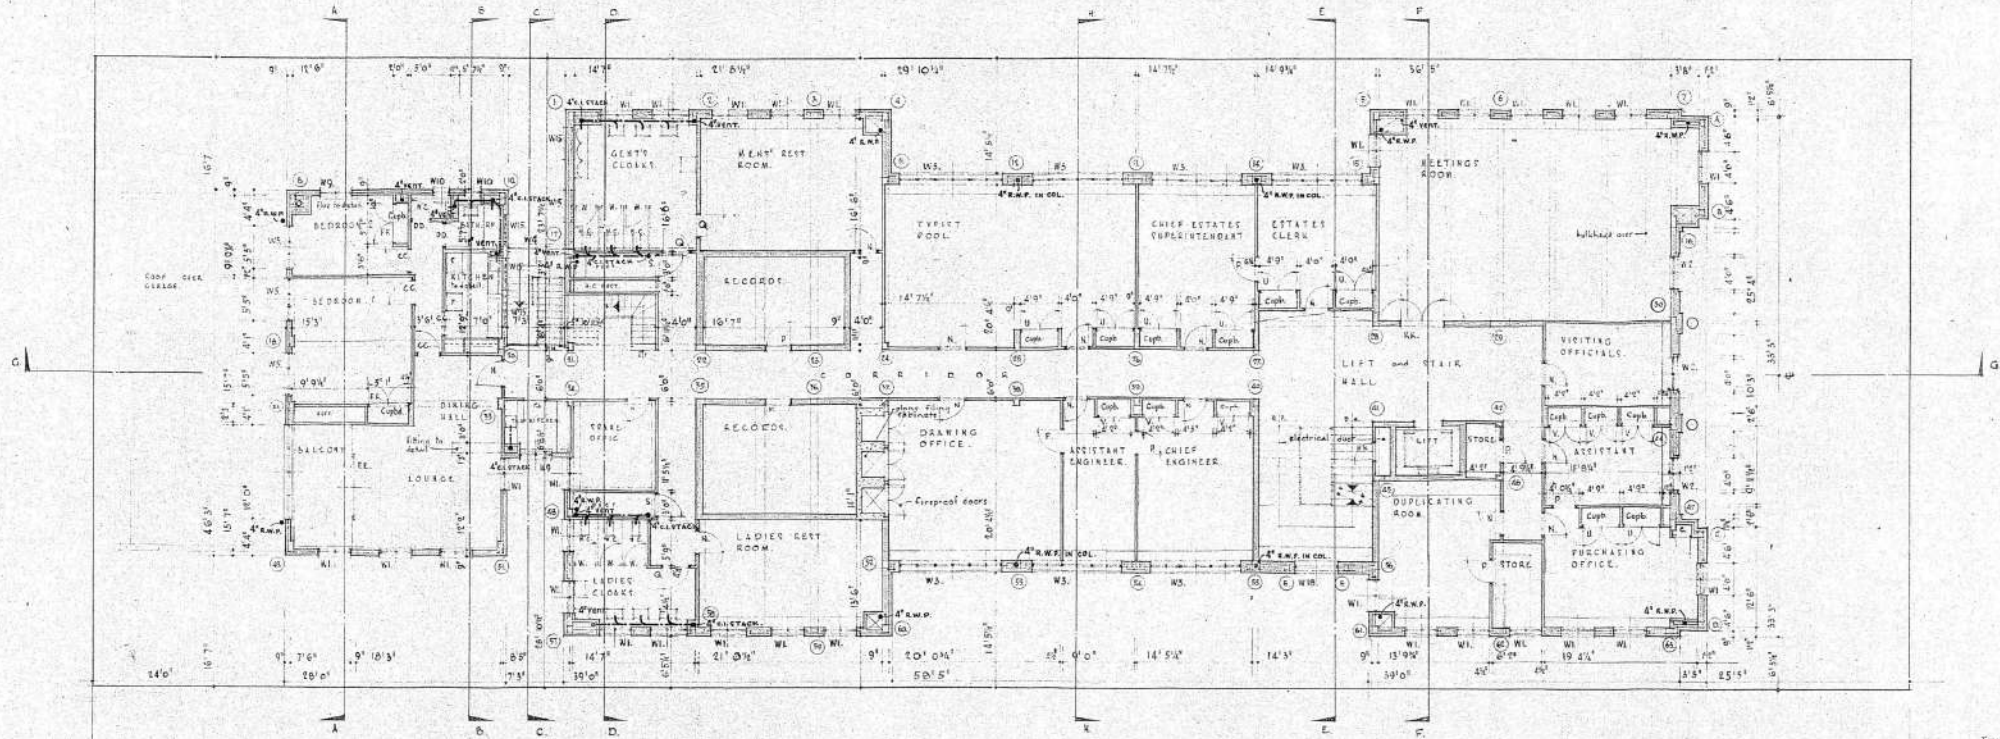


SECOND FLOOR PLAN

For and on behalf of
THE NATAL TANNING EXTRACT CO., LTD.
Hee Bant
MANAGING DIRECTOR & SECRETARY

1/8" SCALE WORKING
DRAWING

NEW OFFICE BLOCK IN LOOP STREET, PIETERMARITZBURG FOR THE NATAL TANNING EXTRACT CO, LTD

SEWERAGE
CHECK, BATHROOMS and TOILET
ARCHITECTS: D. B. & A.
SCALE 1/8" = 1'-0" FEB. 1956
DRAWING NO. 1957/46/P14

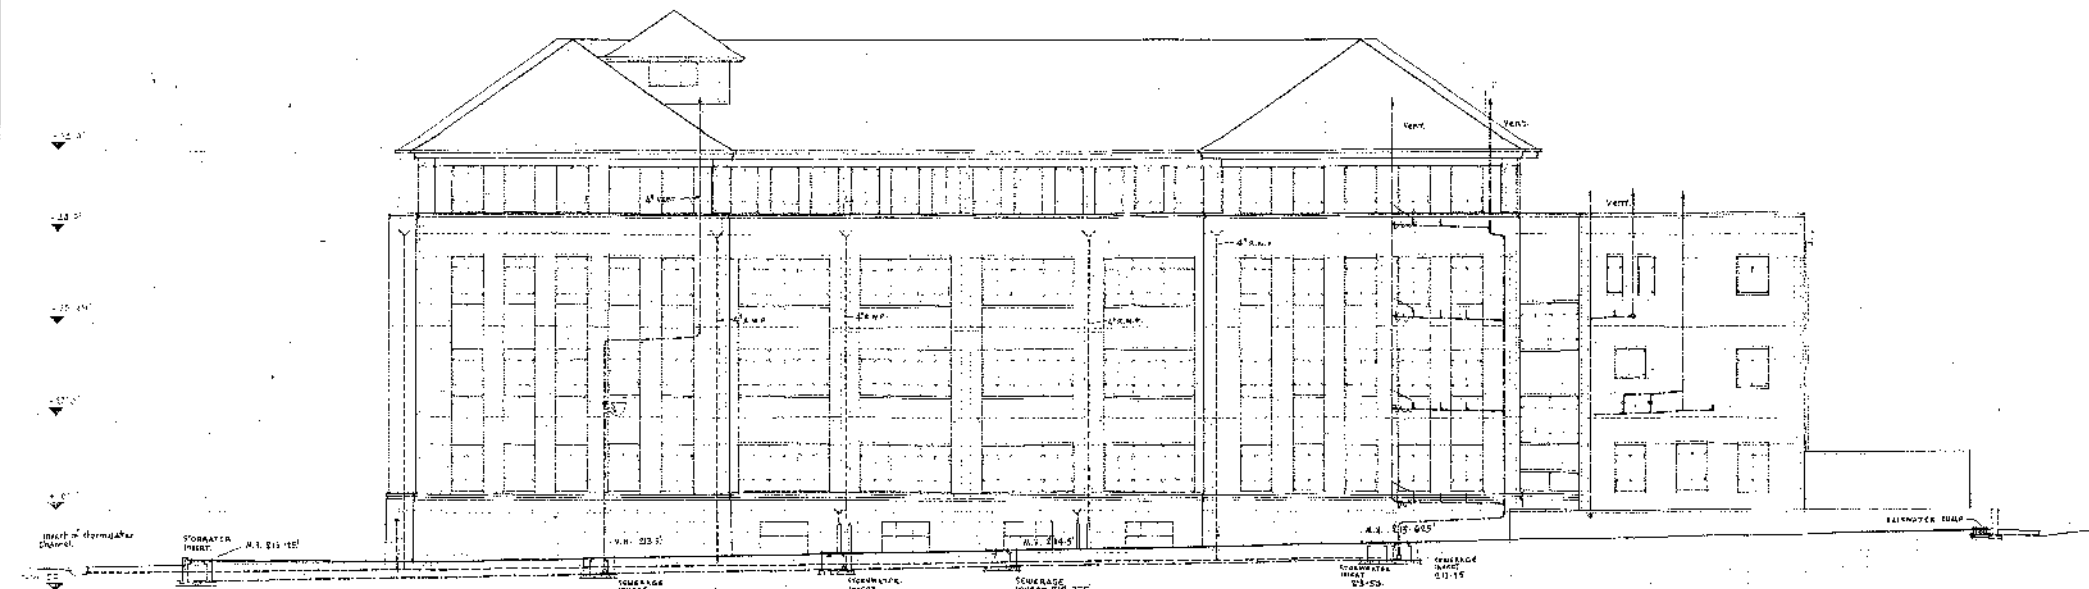

SIDE ELEVATION

1980年10月1日
1980年10月1日

NEW OFFICE BLOCK IN LOOP STREET, PIETERMARITZBURG FOR THE NATAL TANNING EXTRACT CO., LTD.


THE CITY OF

 MAYOR

SEWERAGE.

CHAS. B. FORDHOPE AND SONS
 ENGINEERS
 225 E. 3rd ST. - ST. LOUIS, MO.
 DRAWING NO. 105/5173.

RECEIVED
17 JUN 1956
PLAN No. 235/54

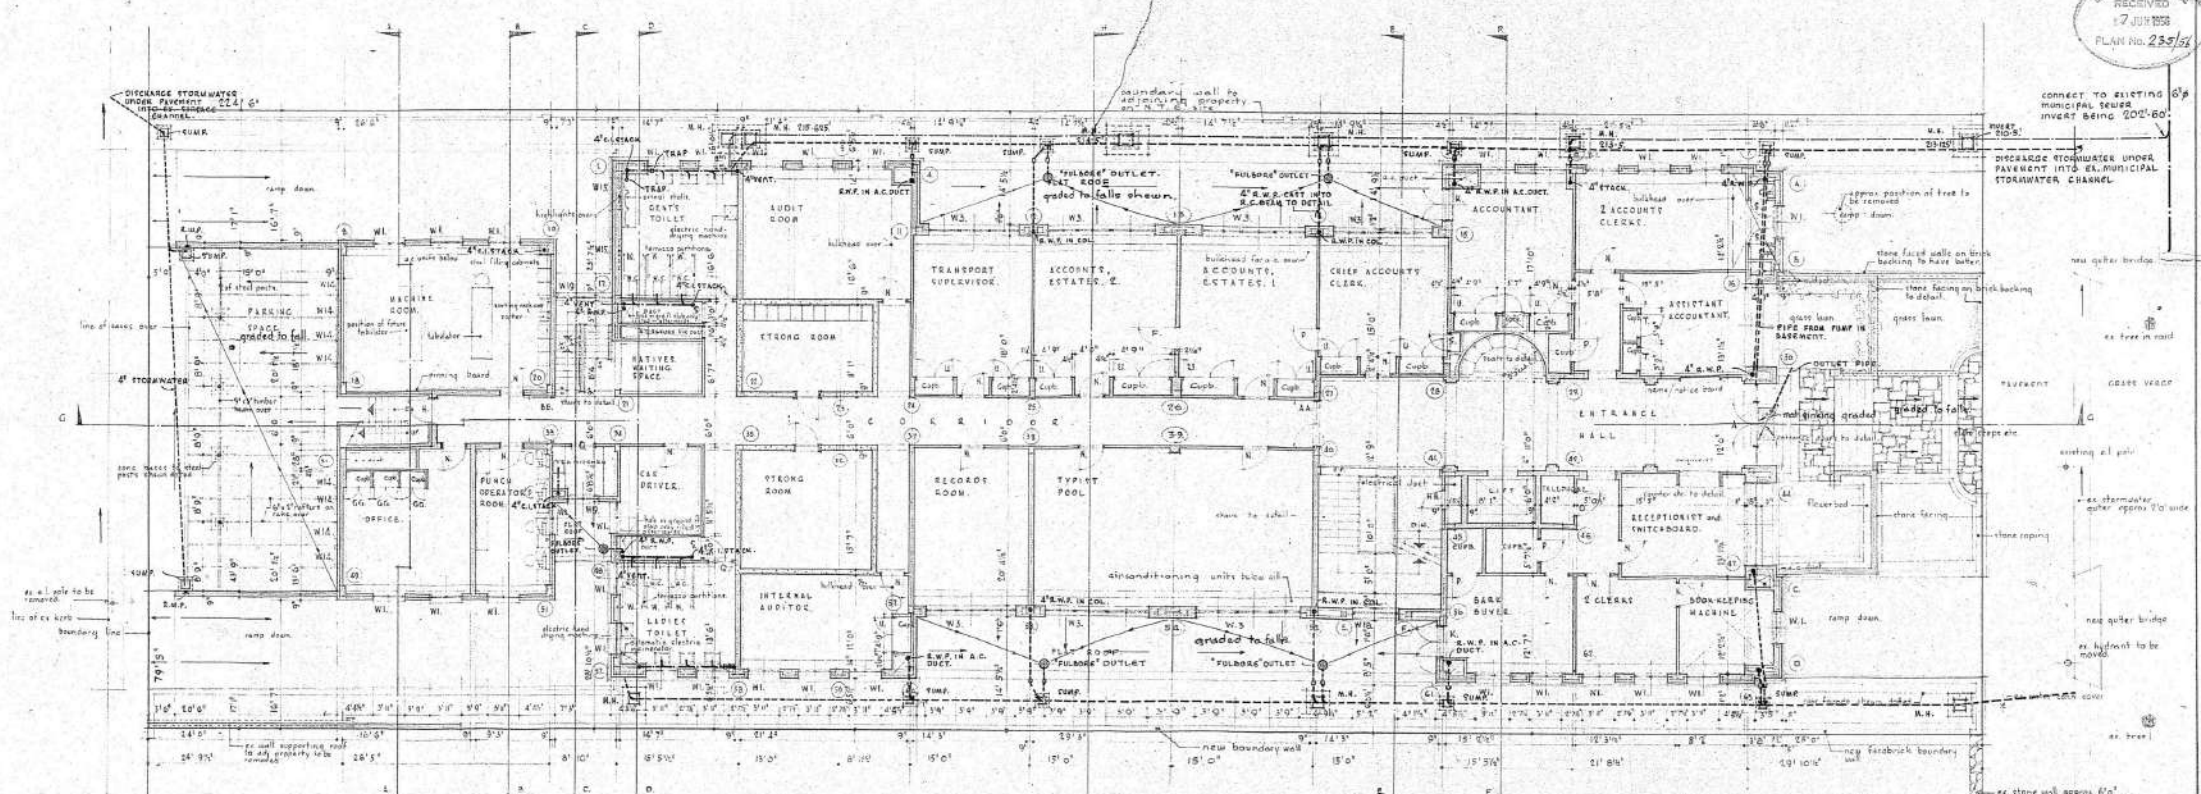



GROUND FLOOR PLAN.

For and on behalf of
THE NATAL TANNING EXTRACT CO., LTD.
W. J. B. B. B.
MANAGER & SECRETARY

1/8" SCALE WORKING
DRAWING

NEW OFFICE BLOCK IN LOOP STREET, PIETERMARITZBURG FOR THE NATAL TANNING EXTRACT CO., LTD

 SEWERAGE.
CHECK, BATHROOMS AND POOL
ARCHITECTS: D. J. B. B. B.
SCALE 6" = 1" FEB. 1956
DRAWING NO. 195744/14

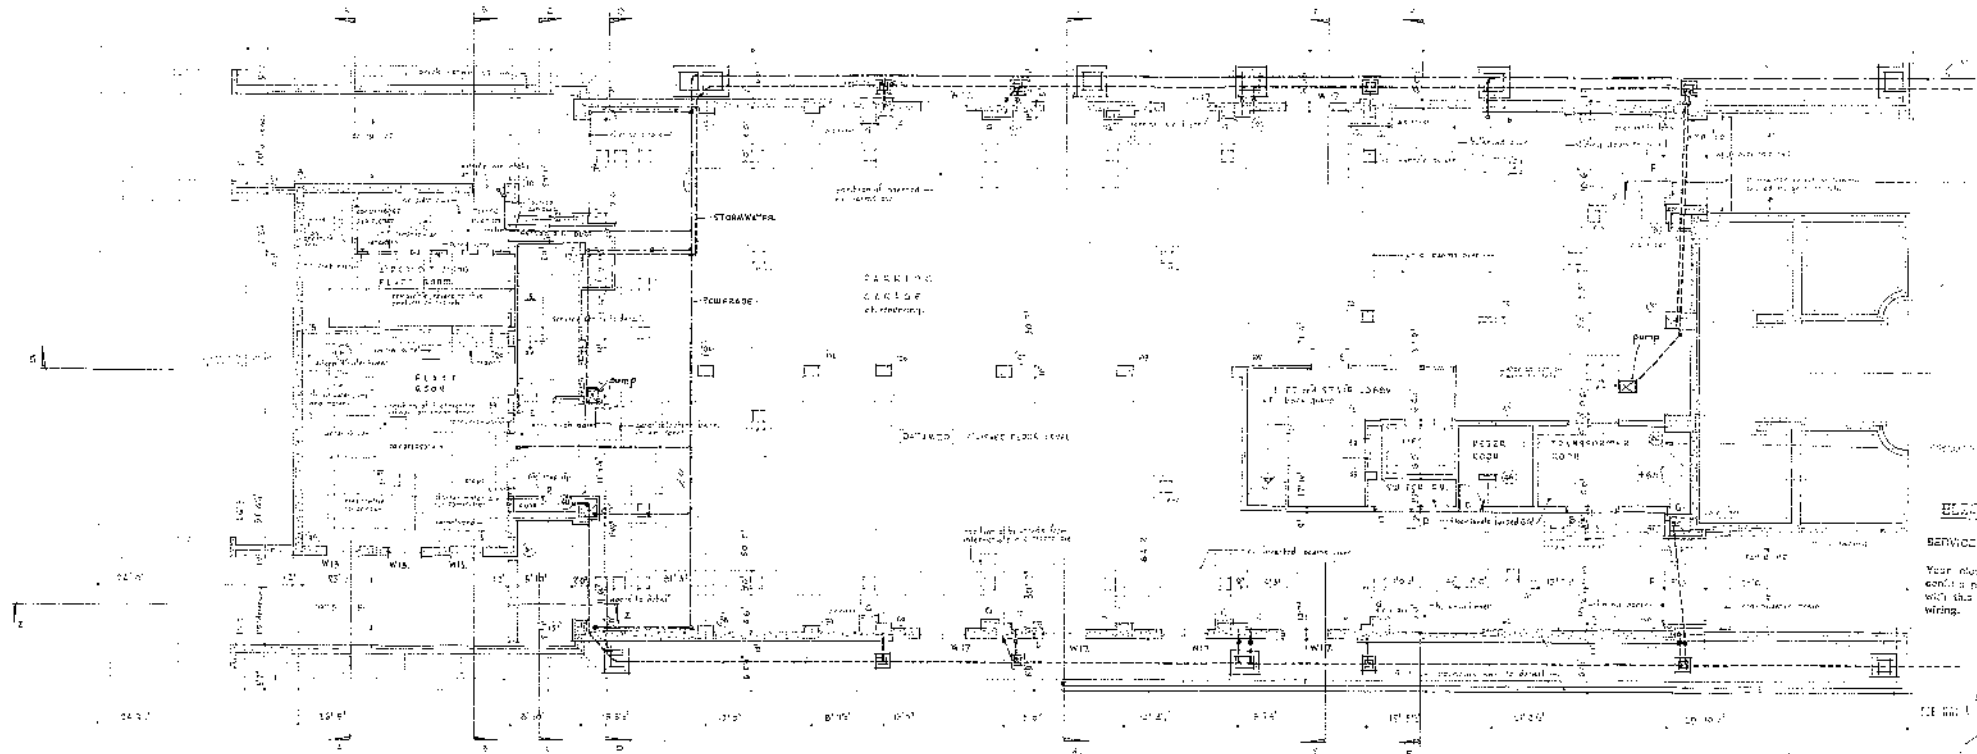

BASMENT PLAN.

ELECTRICAL PLAN

SERVICE WIRE FOR THE BUILDING
Your electrical contractor should consult with the District Engineer before commencing wiring.

SEWERAGE
The sewerage system for the building is shown on the sewerage plan.

NO. 10
ANY WORKMAN SHOULD BE EMPLOYED TO DO THE WORK
ON THE SEWERAGE SYSTEM OF THE BUILDING
DETAILS AND EXISTING LAYOUT
SHOULD BE KEPT ON FILE.

1/4" SCALE APPROX.
DRAWING

NEW OFFICE BLOCK IN LOOP STREET PIETERMARITZBURG FOR THE NATAL TANNING EXTRACT CO, LTD.

SEWERAGE
The sewerage system for the building is shown on the sewerage plan.
The sewerage system for the building is shown on the sewerage plan.
The sewerage system for the building is shown on the sewerage plan.